



5 SITE PLAN
SCALE: 1" = 20'-0"

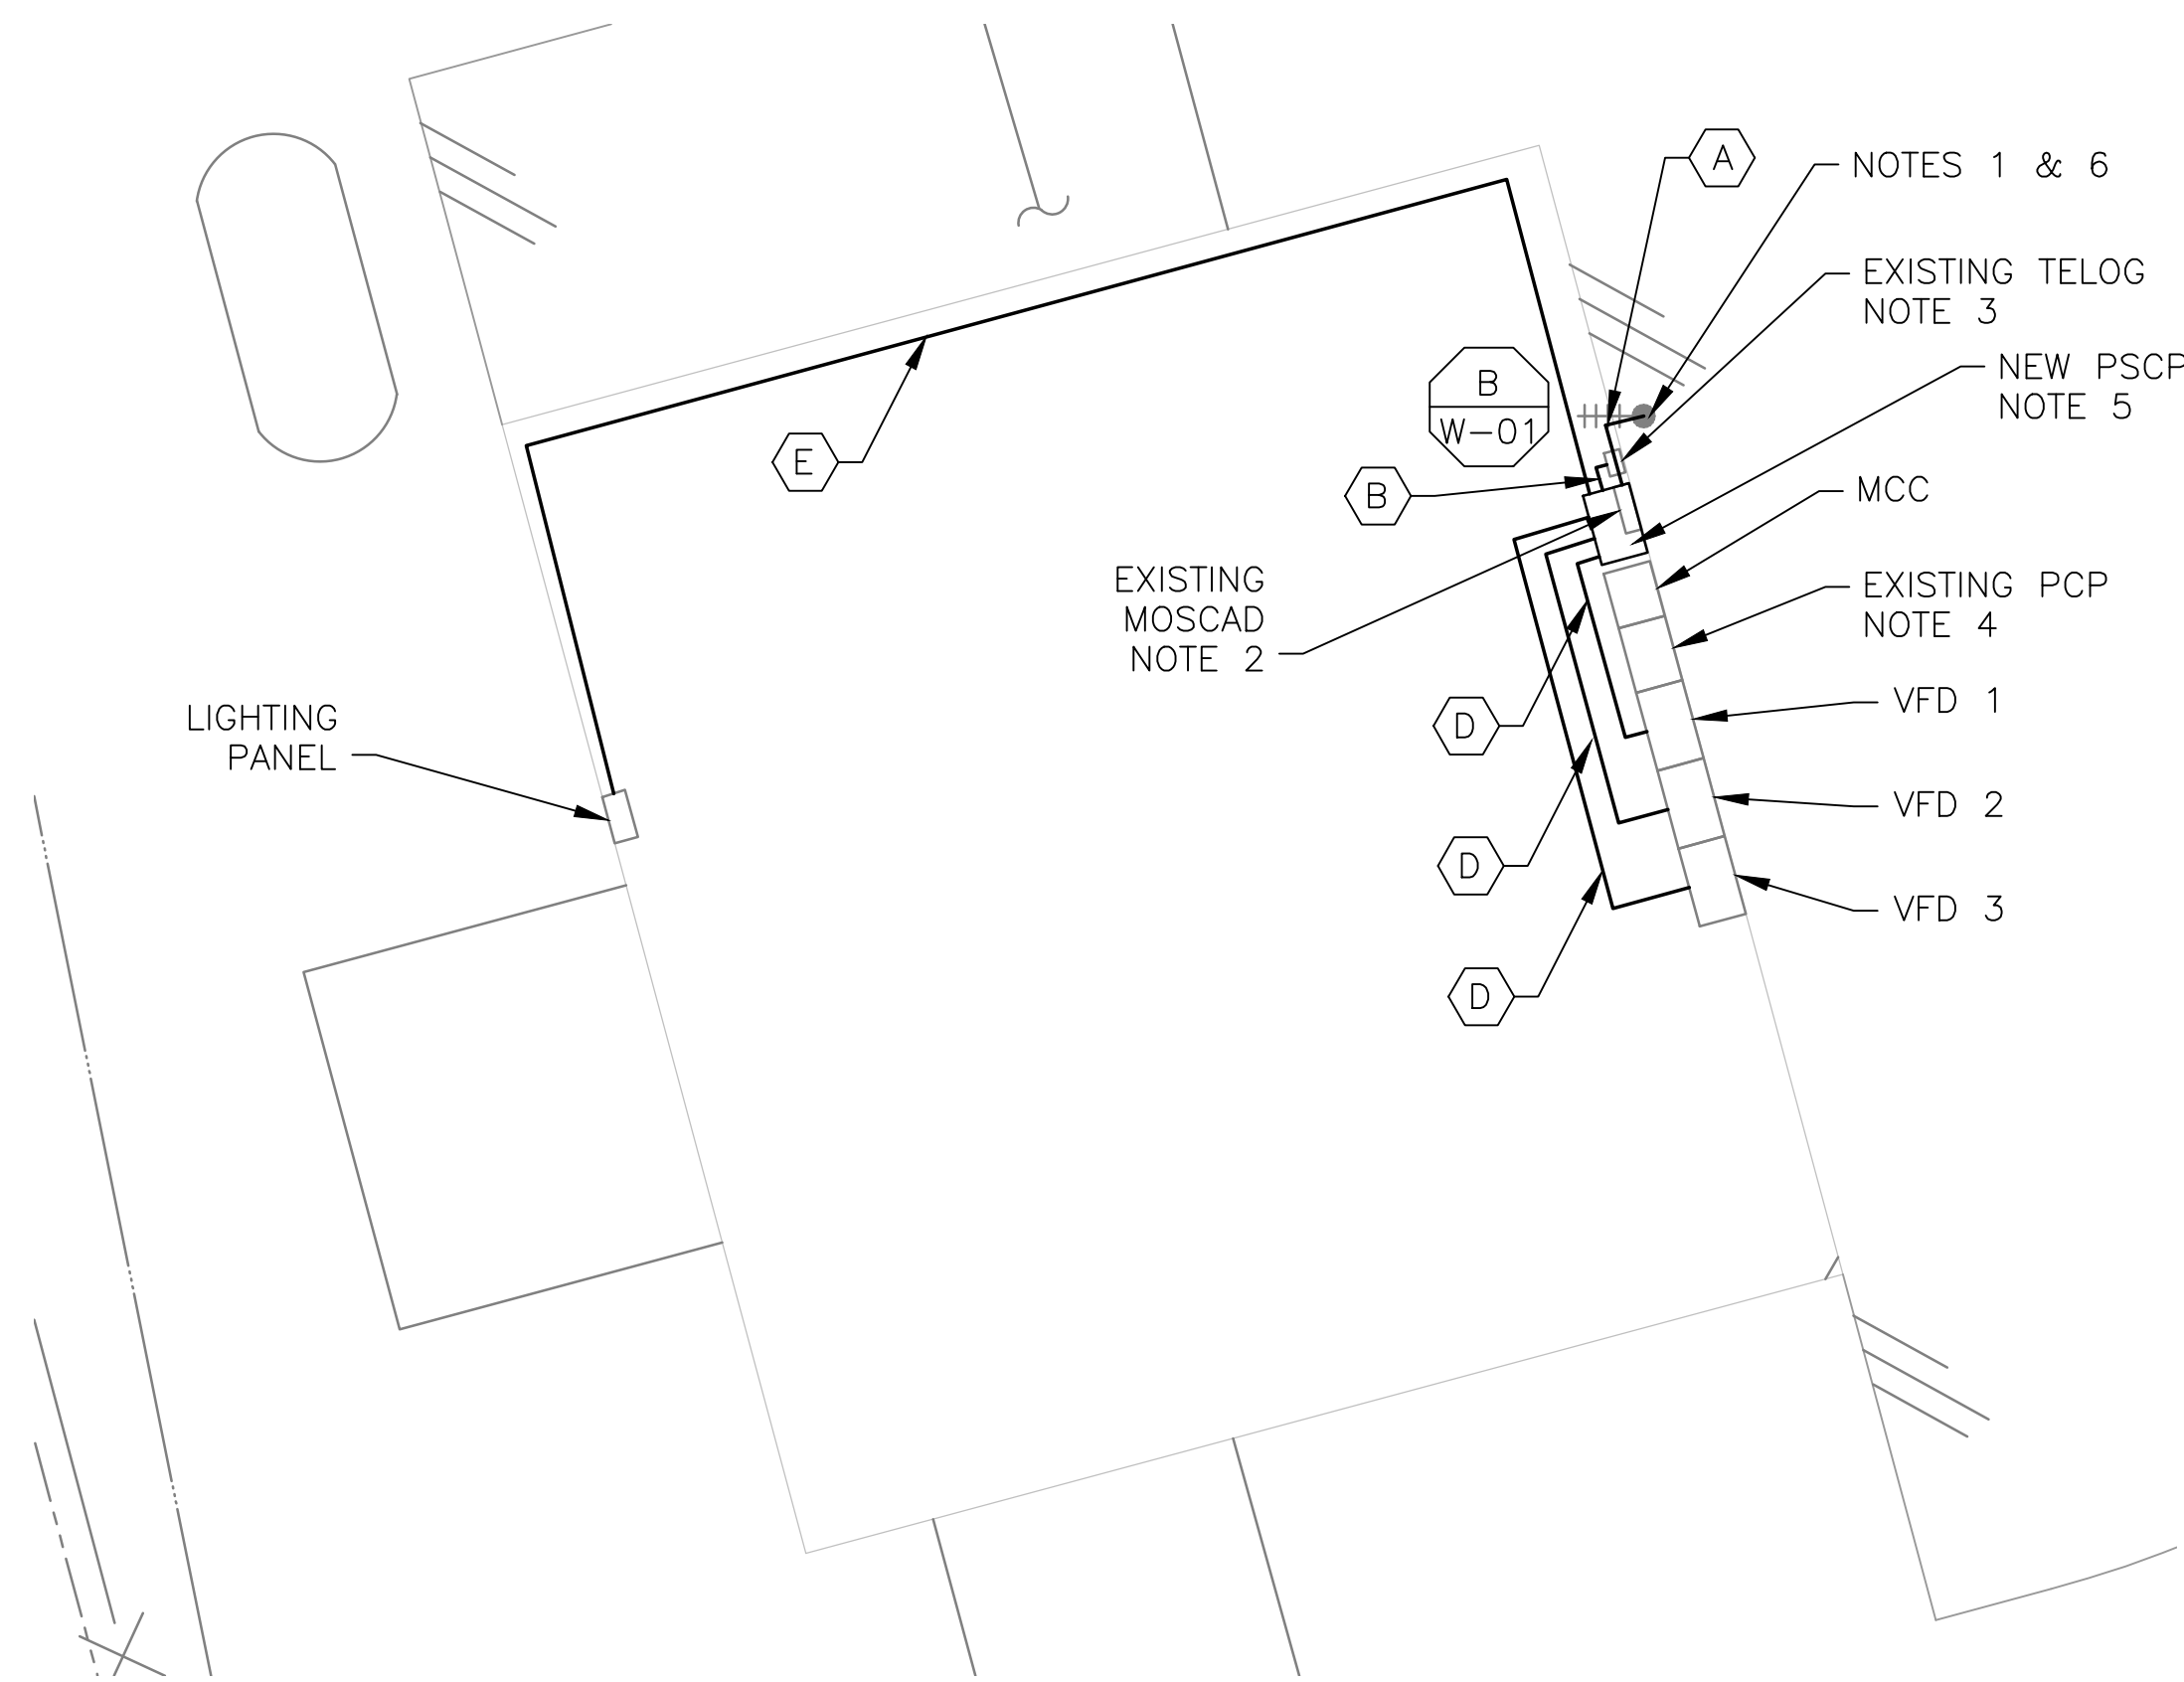


1 ROOM PLAN
SCALE: 1/8" = 1'-0"

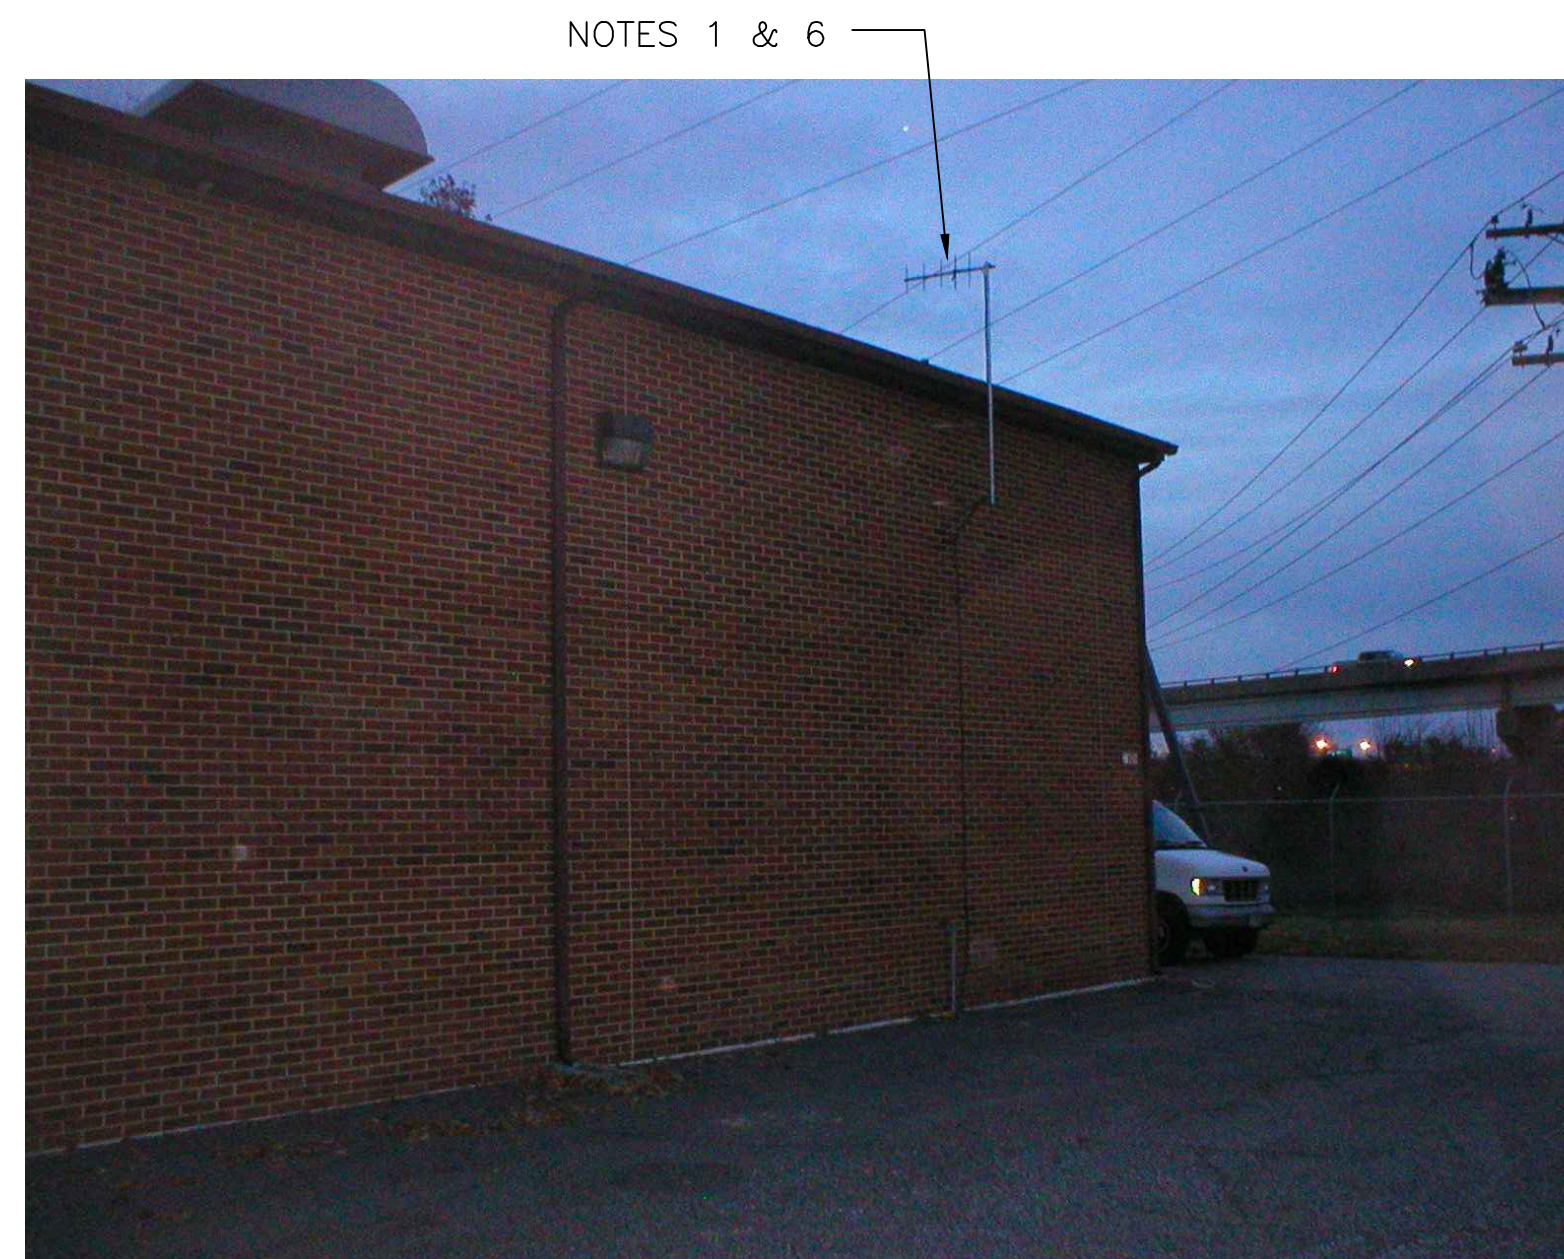

2 EXISTING ANTENNA LOCATION
SCALE: NOT TO SCALE

CONDUIT/CABLE SCHEDULE	
A	ANTENNA CABLE
B	2 #12, 1 #12 GND IN 3/4" C
C	10 #14 IN 3/4" C
D	7 STP IN 1-1/2" C
E	NOT USED
F	16 #14 IN 3/4" C
G	3 STP IN 3/4" C
H	2 #12, 1 #12 GND IN 3/4" C
I	NOT USED

- NOTES:**
- EXISTING YAGI ANTENNA AND CABLE TO BE REMOVED AFTER SUCCESSFUL INSTALLATION OF THE NEW PUMP STATION CONTROL PANEL (PSCP).
 - EXISTING MOSCAD PANEL AND TERMINATION PANEL TO BE TEMPORARILY RELOCATED; THEN REMOVED FROM THE SITE AFTER INSTALLATION AND TESTING OF THE NEW PSCP. REFER TO THE I/O LIST FOR EXISTING MOSCAD ANALOG AND DIGITAL I/O SIGNALS WHICH WILL BE RE-TERMINATED WITHIN THE NEW PSCP.
 - EXISTING TELOG PANEL TO REMAIN. REMOVE EXISTING ANALOG AND DIGITAL INPUTS BETWEEN MOSCAD UNIT AND TELOG UNIT. REPLACE THESE SIGNALS WITH IDENTICAL SIGNALS ORIGINATING FROM THE NEW PSCP.
 - EXISTING PUMP CONTROL PANEL TO REMAIN. REMOVE EXISTING PLC'S, RELAYS, AND CONTROL EQUIPMENT AFTER INSTALLATION AND TESTING OF THE NEW PSCP.
 - REFER TO DRAWING G-13 FOR DETAILS OF THE CONSTRUCTION PHASING REQUIREMENTS FOR THE NEW PSCP.
 - MOVE EXISTING ANTENNA DOWN ON MAST AND INSTALL NEW ANTENNA ON TOP OF MAST. INSTALL NEW ANTENNA CABLE.
 - REFER TO DRAWING G-14 FOR PANEL LAYOUT.
 - TERMINAL BLVD PRS ALSO HAS ALTERNATE CONTROL SETPOINTS FROM DOVERCOURT PS BASED ON ITS WET WELL LEVEL AS DESCRIBED IN SECTION 17960.
 - THE OIT AT EACH SITE SHALL HAVE THE CAPABILITIES TO SEE THE OTHER SITE'S OPERATING PARAMETERS (WET WELL LEVEL, PRS SUCTION AND DISCHARGE PRESSURE, ETC.) AS DESCRIBED IN SECTION 17960.

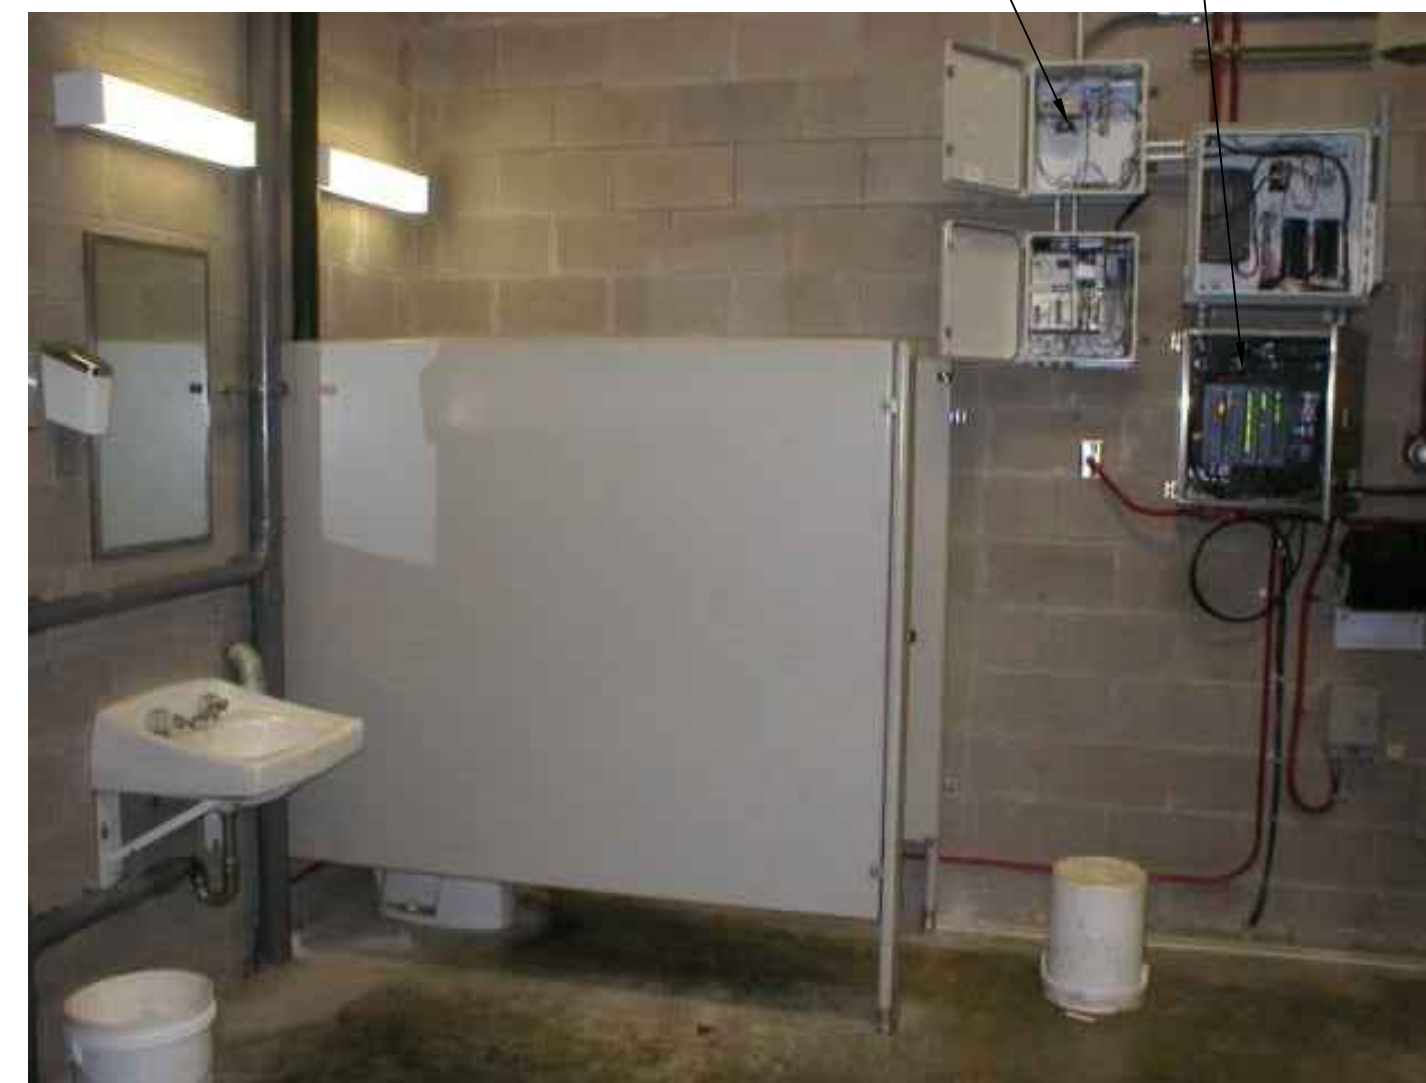

3 EXISTING MOSCAD PANEL
SCALE: NOT TO SCALE




4 EXISTING CONTROL PANEL
SCALE: NOT TO SCALE



ISSUE	DATE	DESCRIPTION
1	MAR 27 2015	CONFORMED DRAWINGS
0	DEC 2014	BID


PROJECT MANAGER:	D. FOOTE
DESIGNED BY:	B. BUTLER
DRAWN BY:	G. BUI
PROJECT NUMBER:	8582

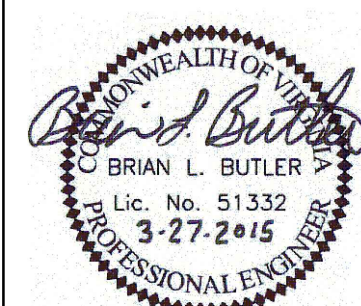

HAMPTON ROADS SANITATION DISTRICT
VIRGINIA BEACH, VIRGINIA

INTERCEPTOR SYSTEMS PUMP STATION
CONTROL AND SCADA

 TERMINAL BLVD
PRESSURE REDUCING STATION
NO 152
SITE PLAN



FILENAME	05152ES21.DWG
SCALE	AS NOTED

DRAWING NUMBER	ES-21
SHEET	107 OF 256