




1 SITE PLAN
SCALE: NTS



2 ANTENNA LOCATION
SCALE: NOT TO SCALE

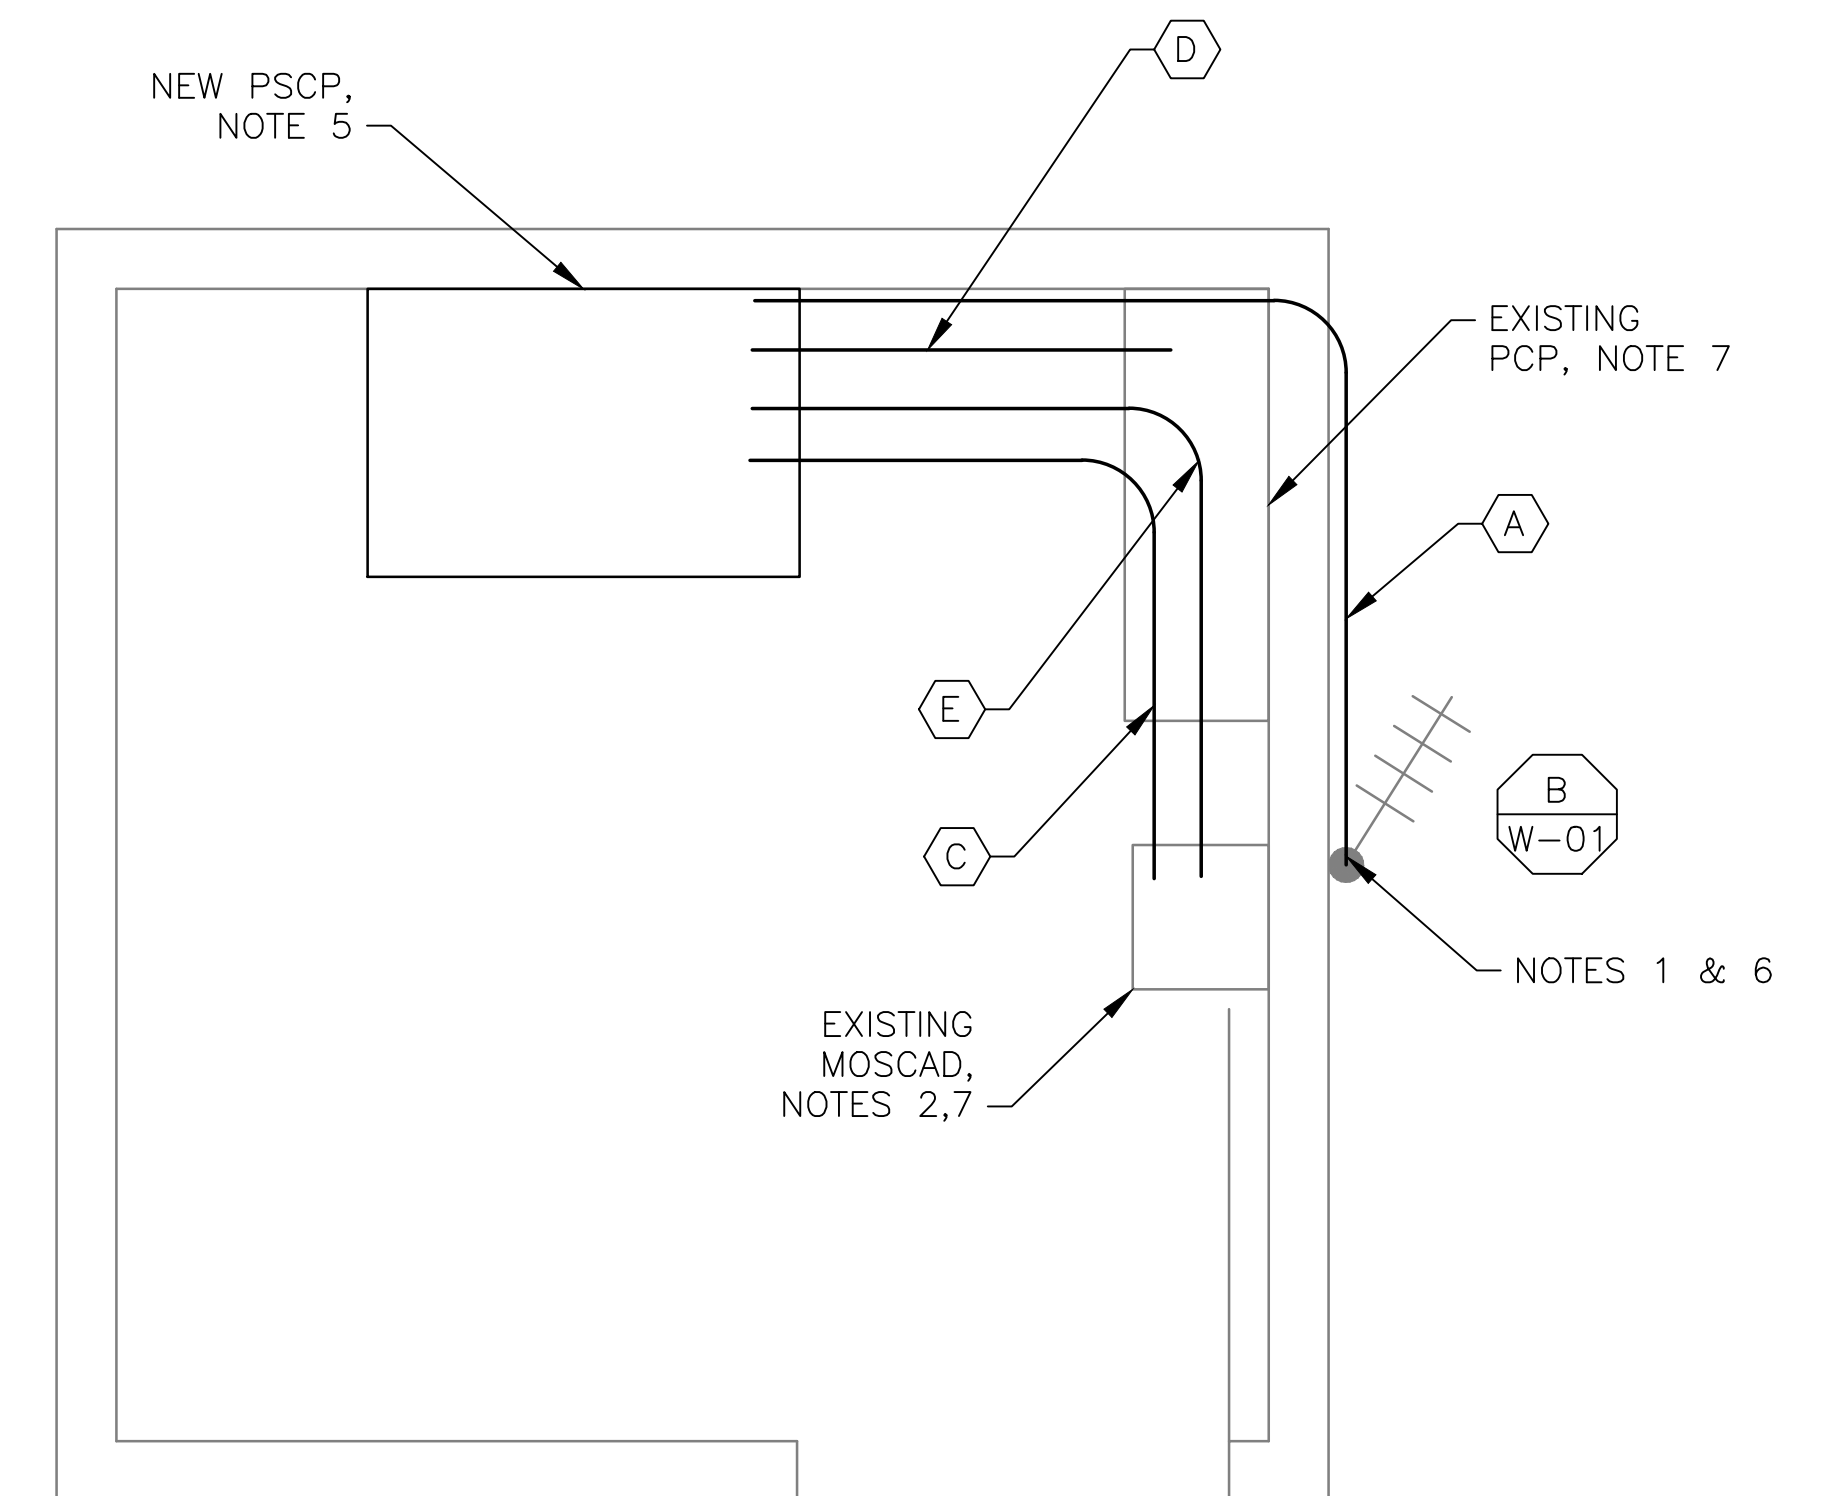

3 FLOOR PLAN
SCALE: 3/4" = 1'-0"


- NOTES:**
- EXISTING YAGI ANTENNA AND CABLE TO BE REMOVED AFTER SUCCESSFUL INSTALLATION OF THE NEW PUMP STATION CONTROL PANEL (PSCP).
 - EXISTING MOSCAD UNIT AND RADIO TO BE REMOVED FROM EXISTING PANEL.
 - NOT USED.
 - NOT USED.
 - REFER TO DRAWING G-11 FOR DETAILS OF THE CONSTRUCTION PHASING REQUIREMENTS FOR THE NEW PSCP.
 - MOVE EXISTING ANTENNA DOWN ON MAST AND INSTALL NEW ANTENNA ON TOP OF MAST. INSTALL NEW ANTENNA CABLE.
 - PROVIDE NEW TERMINAL BLOCKS IN EXISTING PANEL AND EXTEND EXISTING CONTROL WIRING TO THE NEW PSCP.
 - REFER TO DRAWING G-16 FOR PANEL LAYOUT.

| CONDUIT/CABLE SCHEDULE | |
|------------------------|----------------------------|
| (A) | ANTENNA CABLE |
| (B) | NOT USED |
| (C) | 14 #14 IN 3/4" C |
| (D) | 26 #14 IN 1" C |
| (E) | 2 #12, 1 #12 GND IN 3/4" C |



| ISSUE | DATE | DESCRIPTION |
|-------|-------------|--------------------|
| 1 | MAR 27 2015 | CONFORMED DRAWINGS |
| 0 | DEC 2014 | BID |

| | |
|------------------|-----------|
| PROJECT MANAGER: | D. FOOTE |
| DESIGNED BY: | B. BUTLER |
| DRAWN BY: | G. BUI |
| PROJECT NUMBER: | 8582 |

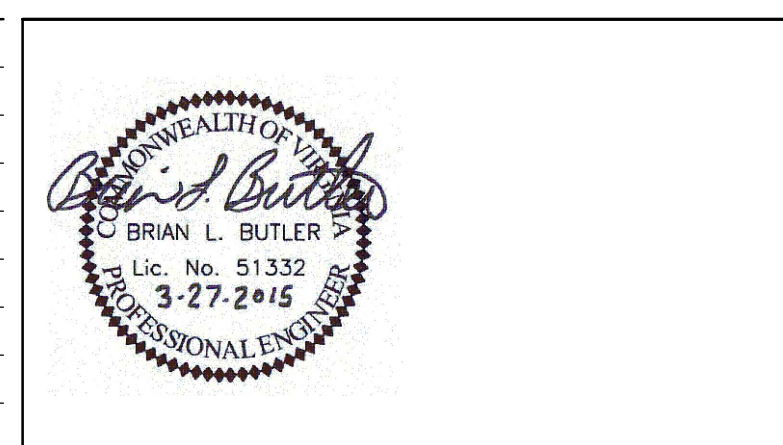

HAMPTON ROADS SANITATION DISTRICT
VIRGINIA BEACH, VIRGINIA

INTERCEPTOR SYSTEMS PUMP STATION
CONTROL AND SCADA

BAGBY AVE
GRAVITY LIFT STATION
NO 9
SITE PLAN

0 1" 2"

| | | | |
|----------|-------------|----------------|------------|
| FILENAME | 069EM34.DWG | DRAWING NUMBER | EM-34 |
| SCALE | AS NOTED | SHEET | 179 OF 256 |